



LEGEND
 SHADED UNIT HEATERS ARE NEW
 UNSHADED UNIT HEATERS & RADIATION IS EXISTING
 SHADED TRAPS ARE NEW
 UNSHADED TRAPS ARE EXISTING
 ——— EXISTING STEAM SUPPLY PIPING
 - - - EXISTING STEAM RETURN PIPING
 ——— NEW STEAM SUPPLY PIPING
 - - - NEW STEAM RETURN PIPING
 — PD — CONDENSATE PUMP DISCHARGE


COMM. NO. 6516	BASEMENT PLAN	SCALE 1/4" = 1'-0"
DATE SEPT 15, 1945	ALTERATIONS TO HEATING PLANT GYER GYM, CUMBERLAND, ME.	DRAWN R.M.
	ALLIED ENGINEERING INCORPORATED PORTLAND, MAINE	APPROVED 1 OF 3

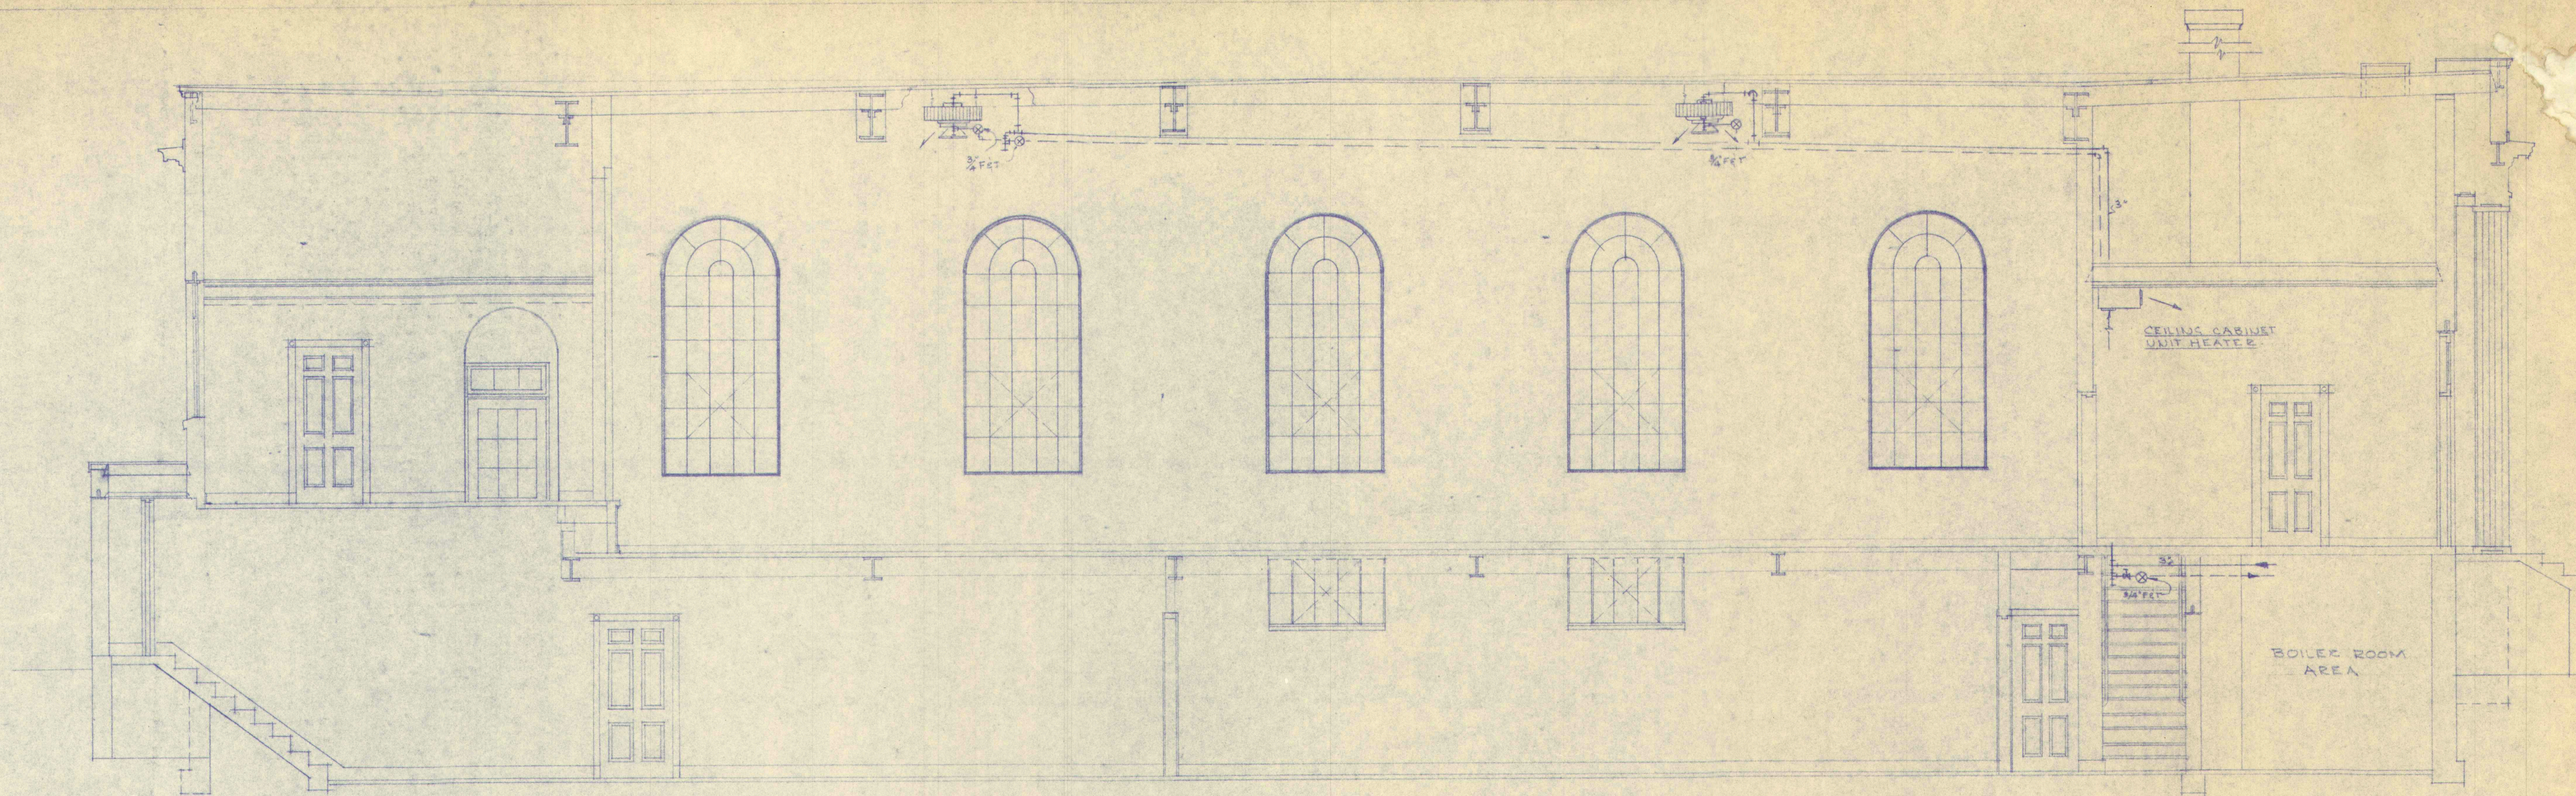


BUILDING CROSS SECTION
SCALE 1/4" = 1'-0"

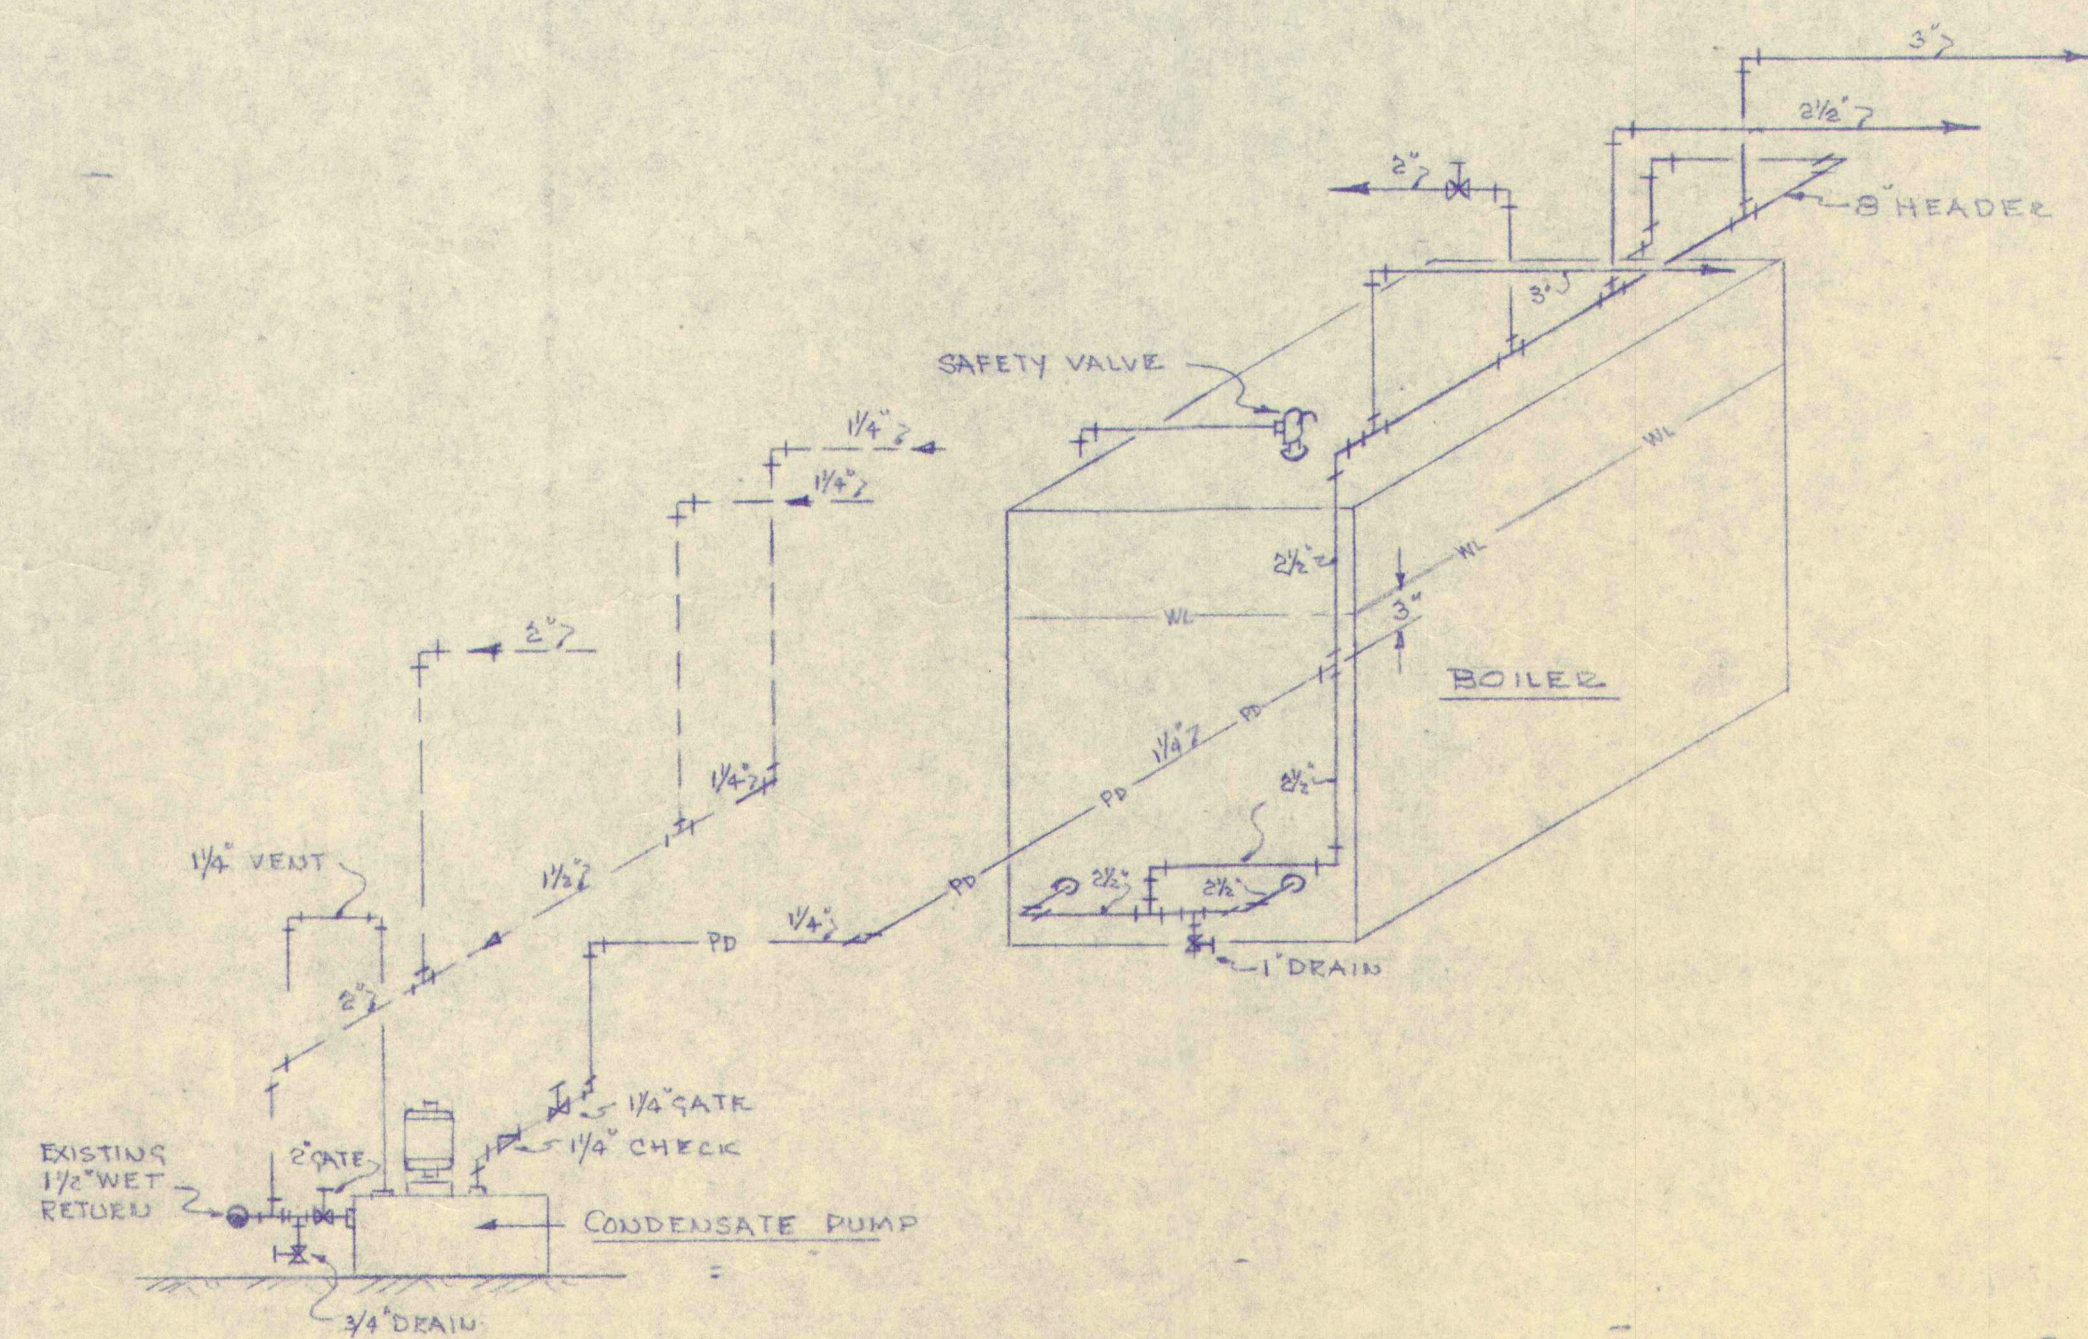

DIAGRAMATIC BOILER ROOM
STEAM PIPING
NO SCALE

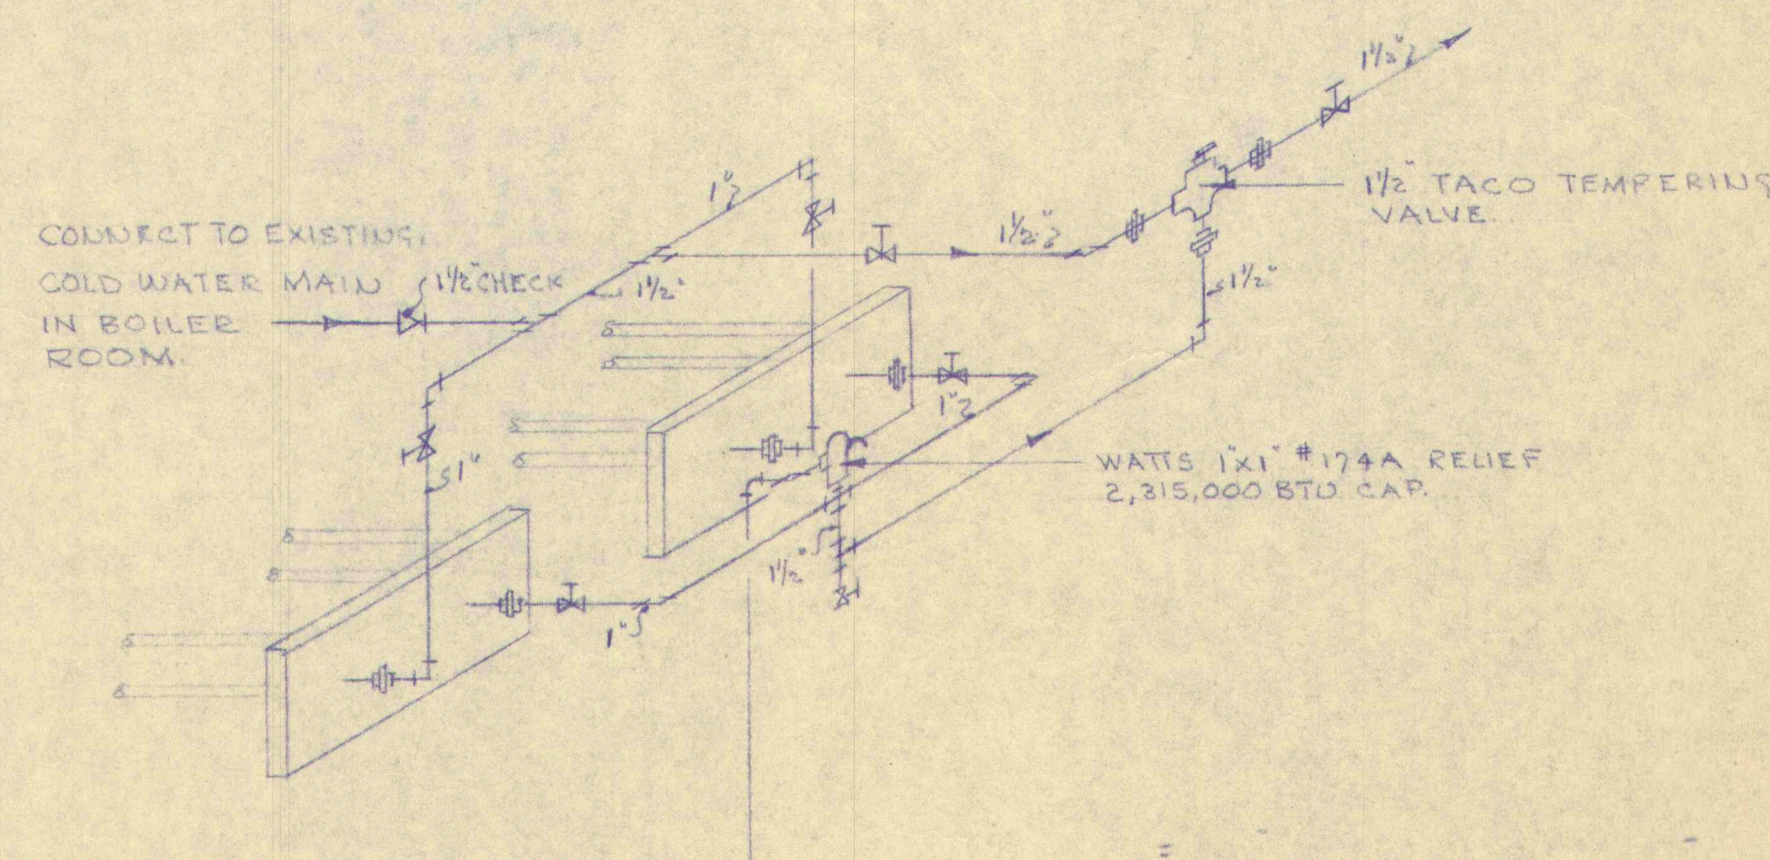

DIAGRAMATIC IMMERSION WATER
HEATER PIPING
NO SCALE

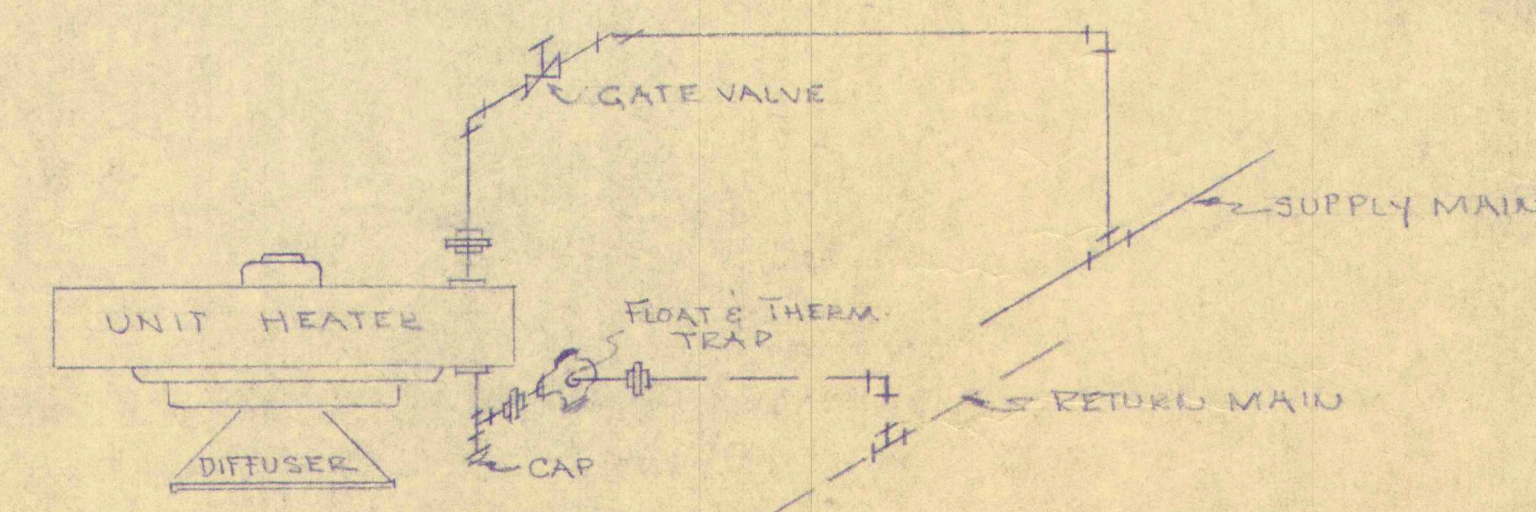

TYPICAL UNIT VENTILATOR
PIPING
NO SCALE

COMM. NO. 6516	BUILDING CROSS SECTION AND PIPING DETAILS	SCALE AS SHOWN
DATE SEPT. 15, 1949	ALTERATIONS TO HEATING PLANT GYGER GYM, CUMBEELAND ME.	DRAWN E.M. APPROVED
	ALLIED ENGINEERING INCORPORATED PORTLAND, MAINE	3 OF 5